


THIS IS A MASTER LAYOUT:
NOT ALL UNITS ARE
EQUIPPED
WITH ALL OF THESE
CIRCUITS/LOADS

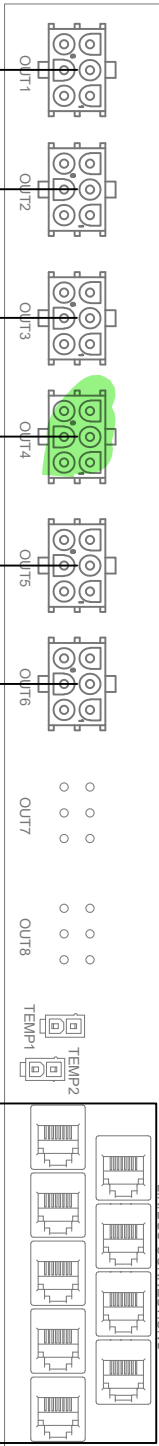

- (1) F1 16 PINK (LIVRM CEILING LTS)
- (2) F2 16 RED/PINK (LIVRM ACCENT LTS)
- (3) F3 18 PINK/WHIT (SOFA 1 READING LTS)
- (4) F4 18 PINK/BLK (SOFA 2 READING LTS)
- (5) F5 16 GRN (WALL LIGHT 1)
- (6) F6 16 GRN/BLK (WALL LIGHT 2)


- (1) F7 18 YEL (HALLWAY LTS)
- (2) F8 18 PUR/WHIT (DINETTE READING LTS)
- (3) F9 16 PUR/BLK (DINETTE DECOR LT)
- (4) F10 16 PUR (KITCHEN CEILING LTS)
- (5) F11 18 PUR/YEL (KITCHEN OH LTS)
- (6) F12 16 PUR/ORNG (KITCHEN ACCENT LTS)

- (1) F13 18 YEL/BLK (BEDRM 1 READING LT)
- (2) F14 18 RED/BLK (BEDRM 2 READING LT)
- (3) F15 16 RED (BEDROOM CEILING LTS)
- (4) F16 16 RED/WHIT (BEDROOM DRESSER LTS)
- (5) F17 18 RED/YEL (BEDROOM ACCENT LTS)
- (6) F18 18 GRN (CLOSET LTS)

- (1) F31 16 GRN/RED (ENTRY STEP SIG)
- (2) F32 18 ORG (AWNING PWR)
- (3) F33 18 PINK/WHIT (BED LIFT SOLENOID SIG)
- (4) OPEN
- (5) OPEN
- (6) OPEN

- (1) F25 16 GRN/YEL (AISLE LTS)
- (2) F26 18 BLK (PORCH LT)
- (3) F27 18 BLK/WHIT (AWNING 1 LT)
- (4) F28 18 ORG/BLK (AWNING 2 LT)
- (5) F29 16 GRN/RED (EXTERIOR ACCENT LTS)
- (6) F30 16 RED (CARGO LTS)


- (1) F19 18 BLU (BATH 1 CEILING LTS)
- (2) F20 14 BLU (BATH 1 VANITY LTS)
- (3) F21 16 GRV/WHIT (BATH 1 FAN)
- (4) F22 18 BLU/WHIT (BATH 2 CEILING LTS)
- (5) F23 18 ORG (BATH 2 VANITY)
- (6) F24 16 GRV/BLK (BATH 2 FAN)

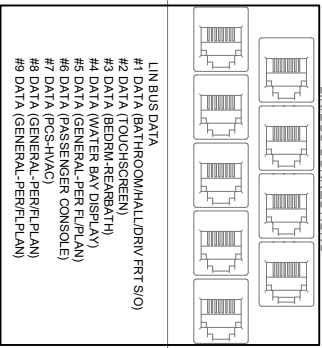

ON/OFF, LIGHTING CIRCUITS, DATA

TOLERANCES ON MACHINED PARTS				DATE	
INCHES				4/2/21	
METRIC				DATE	
XX ± .06				CHECKED	
XX ± .03				DATE	
XX ± .03				ALL OTHER PARTS AND ASSEMBLY TOLERANCES SHOULD BE HELD AS CLOSE AS POSSIBLE	
UNIT:				USAGE OF THE INFORMATION CONTAINED ON THIS DOCUMENT IS CONTINGENT ON THE AGREEMENT TO THE CONDITIONS STATED ON PAGE 1	
ALL MODELS				TITLE	
				LIGHTING/ON-OFF/DATA CIRCUITS	
				SIZE	
				DWG/PRINT NUMBER:	
				0620-500968	
				REV:	
				A	
				SHEETS:	
				3/9	

FOREST RIVER
DIESEL MOTOR HOME DIVISION

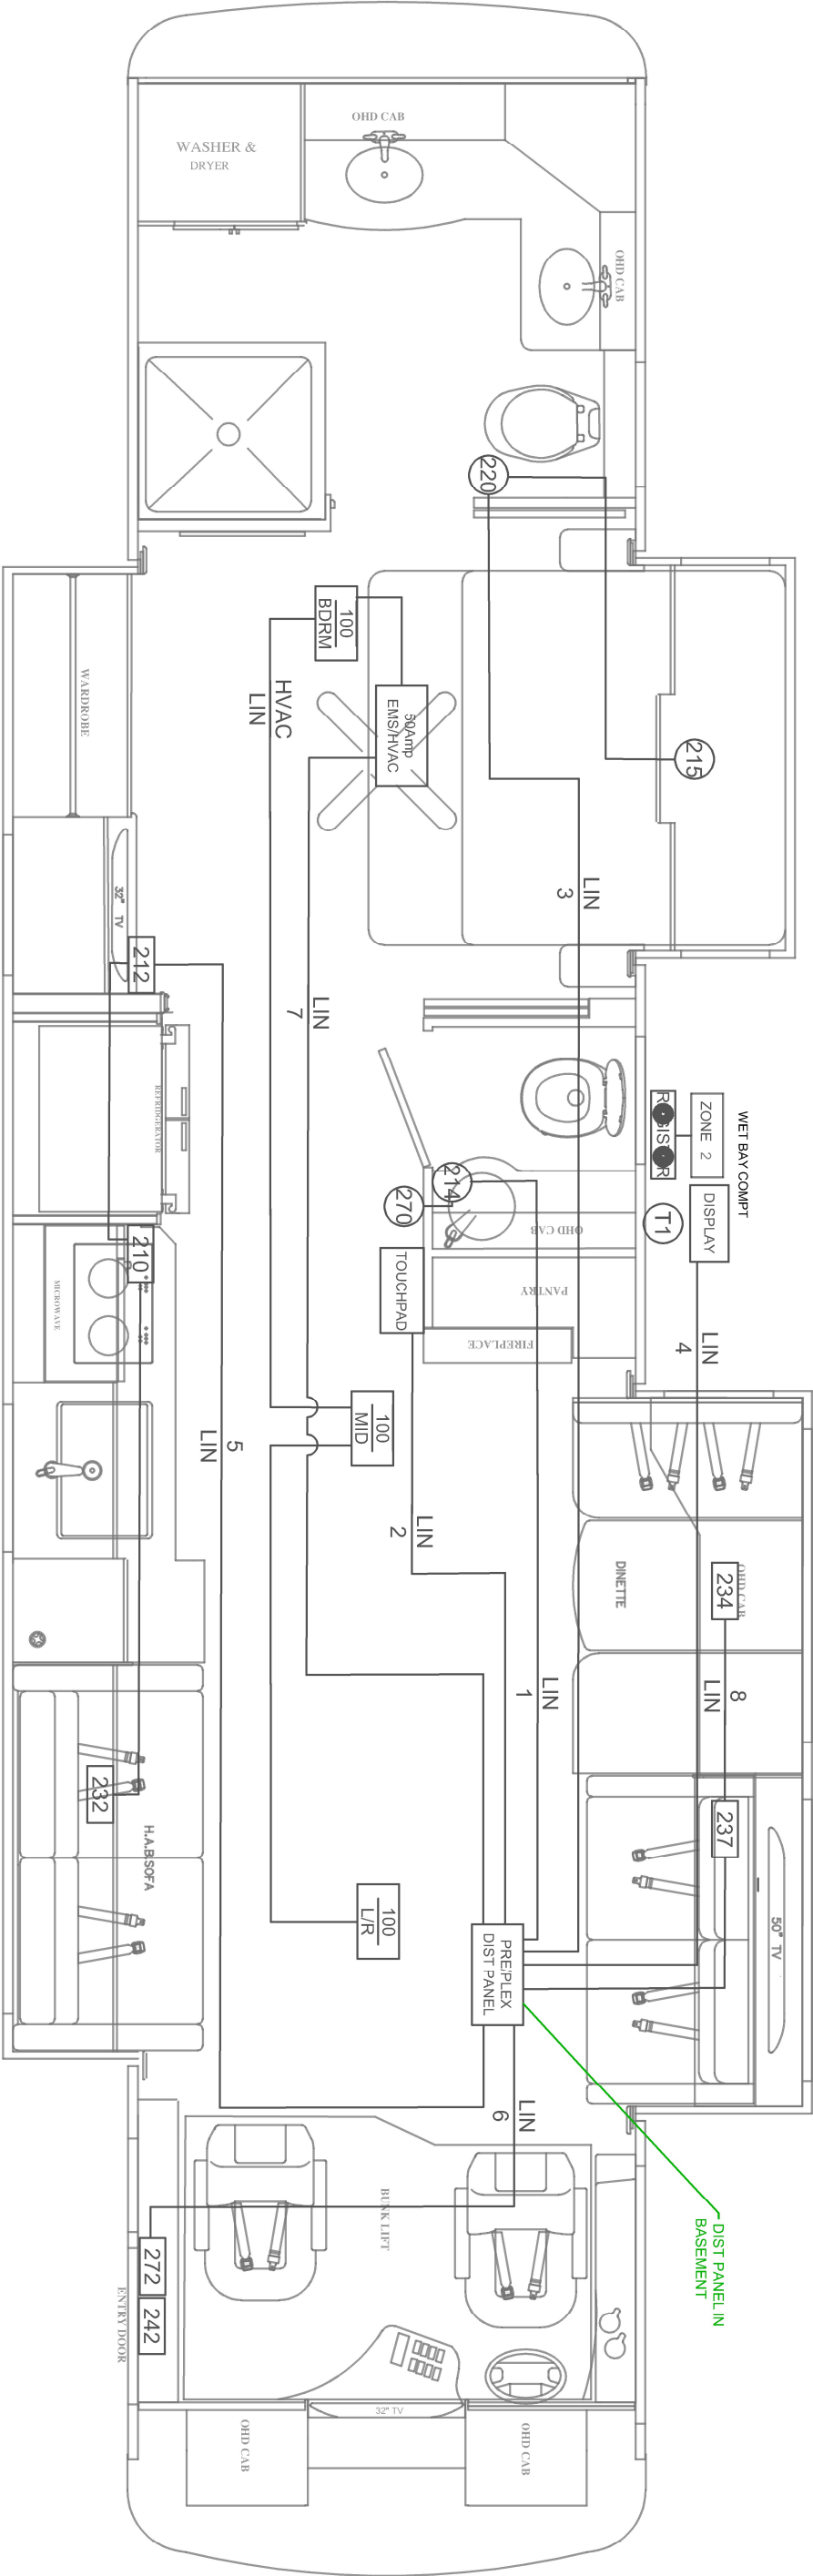

MULTI PLEX PART LIST		
QTY	DESCRIPTION (STD)	PreciP P/N
1	7" TOUCH SCREEN	00-10104-005
1	MASTER PANEL	00-10116-001
1	50 AMP w/PCS (12 STAB)	00-10020-170
1	50 AMP (12 STAB)	00-10020-100
4	110V RELAY (1 BlcHtr/1 FctTV/2 FHH)	00-10026-200
3	TANK MODULE, PRESSURE	00-10082-224
1	TANK BAY DISPLAY	00-10086-000
3	HVAC MODULE (HI SIG) 1 PER AC	00-10058-100
6	THM NUGGET (4 HVAC/1 AM3/1 TNK)	00-10075-000
-	SHADE MODULE	00-10118-400
SWITCHES		
1	KIT/LR WALL SW (4 POS)	00-10098J210
-	HALL WALL SW (4 POS)	00-10098J211
1	BDRM WALL SW (4 POS)	00-10098J212
-	DINETTE SW (8 POS)	00-10099J271
1	BATH 1 SW (8 POS)	00-10099K214

MULTI PLEX PART LIST		
QTY	DESCRIPTION (STD)	PreciP P/N
1	BED OH SW (8 POS)	00-10099J215
-	ACCENT/TV SW (4 POS)	00-10098J216
1	BATH 2 SW (8 POS)	00-10099K220
-	S/O SOFA 2 (4 POS)	00-10098J221
-	HALL WALL SW (4 POS)	00-10098K231
1	S/O SOFA (4 POS)	00-10098K232
-	BUNKRM SW (4 POS)	00-10098J233
1	DINETTE SW (4 POS)	00-10098J234
-	TV LIFT SW (4 POS)	00-10098J235
-	SOFA SW (4 POS)	00-10098J236
1	2ND SOFA SW (4 POS)	00-10098J237
-	3RD SOFA SW (4 POS)	00-10098J238
-	STOOL SW (4 POS)	00-10098J239
1	KIT WALL SW (4 POS)	00-10098J270
1	ENTRY SW (4 POS)	00-10098K272
-	BED OH DRESS SHADE SW (4 POS)	00-10098K273
1	ENTRY DOOR AWNING SW (8 POS)	00-10099K242

MULTI PLEX PART LIST		
QTY	DESCRIPTION (STD)	PreciP P/N
-	HALL SW (4 POS)	00-10098J240
-	BED OH SHADE SW (8 POS)	00-10099K274
-	BEDRM WALL SW W/SHADE (8 POS)	00-10099K275

HVAC LAYOUT		
DISPLAY INFO	DEVICE	THERMISTOR LOCATION
BEDROOM	REAR A/C	215
	HYD HEAT ZONE 4	215
LIVING ROOM	MID-SHIP AC	270
KITCHEN	FRONT AC	270
	HYD HEAT ZONE 1	270
BATH 1	HYD HEAT ZONE 3	214
COMPARTMENT	HYD HEAT ZONE 2	T1 (MASTER)
OUTSIDE	AMBIENT AIR TEMP	T2 (MASTER)
REAR BATH	HYD HEAT ZONE 5	220

TOLERANCES ON MACHINED PARTS.			DRAWN: BMAIN		DATE 2/27/24		FOREST RIVER INC DIESEL MOTOR HOME DIVISION		
INCHES	METRIC	ALL OTHER PARTS AND ASSEMBLY TOLERANCES SHOULD BE HELD AS CLOSE AS POSSIBLE.	MATERIAL: Code	PRINT LOCATION: SYSTEMS					
.XX ± .05	X .3mm .XX 10mm		APPLICATION: Electrical	DO NOT SCALE DRAWING					
MODEL(S):		FLOORPLAN(S):		USAGE OF THE INFOMATION CONTAINED ON THIS DOCUMENT IS CONTINGENT ON AGREEMENT TO THE CONDITIONS STATED ON PAGE 1.					
BERKSHIRE, BERKSHIRE XL, BERKSHIRE XLT, CHARLESTON		ALL, ----, ----,							
TITLE					mplex LAYOUT, , 40H_LIN				
DWG/PRINT NUMBER: 0620-500962.dwg									
REV: C									
PAGE:									

mplex LAYOUT, , 40H LIN